



PAINE RESERVE CHANGE ROOMS AND AMENITIES



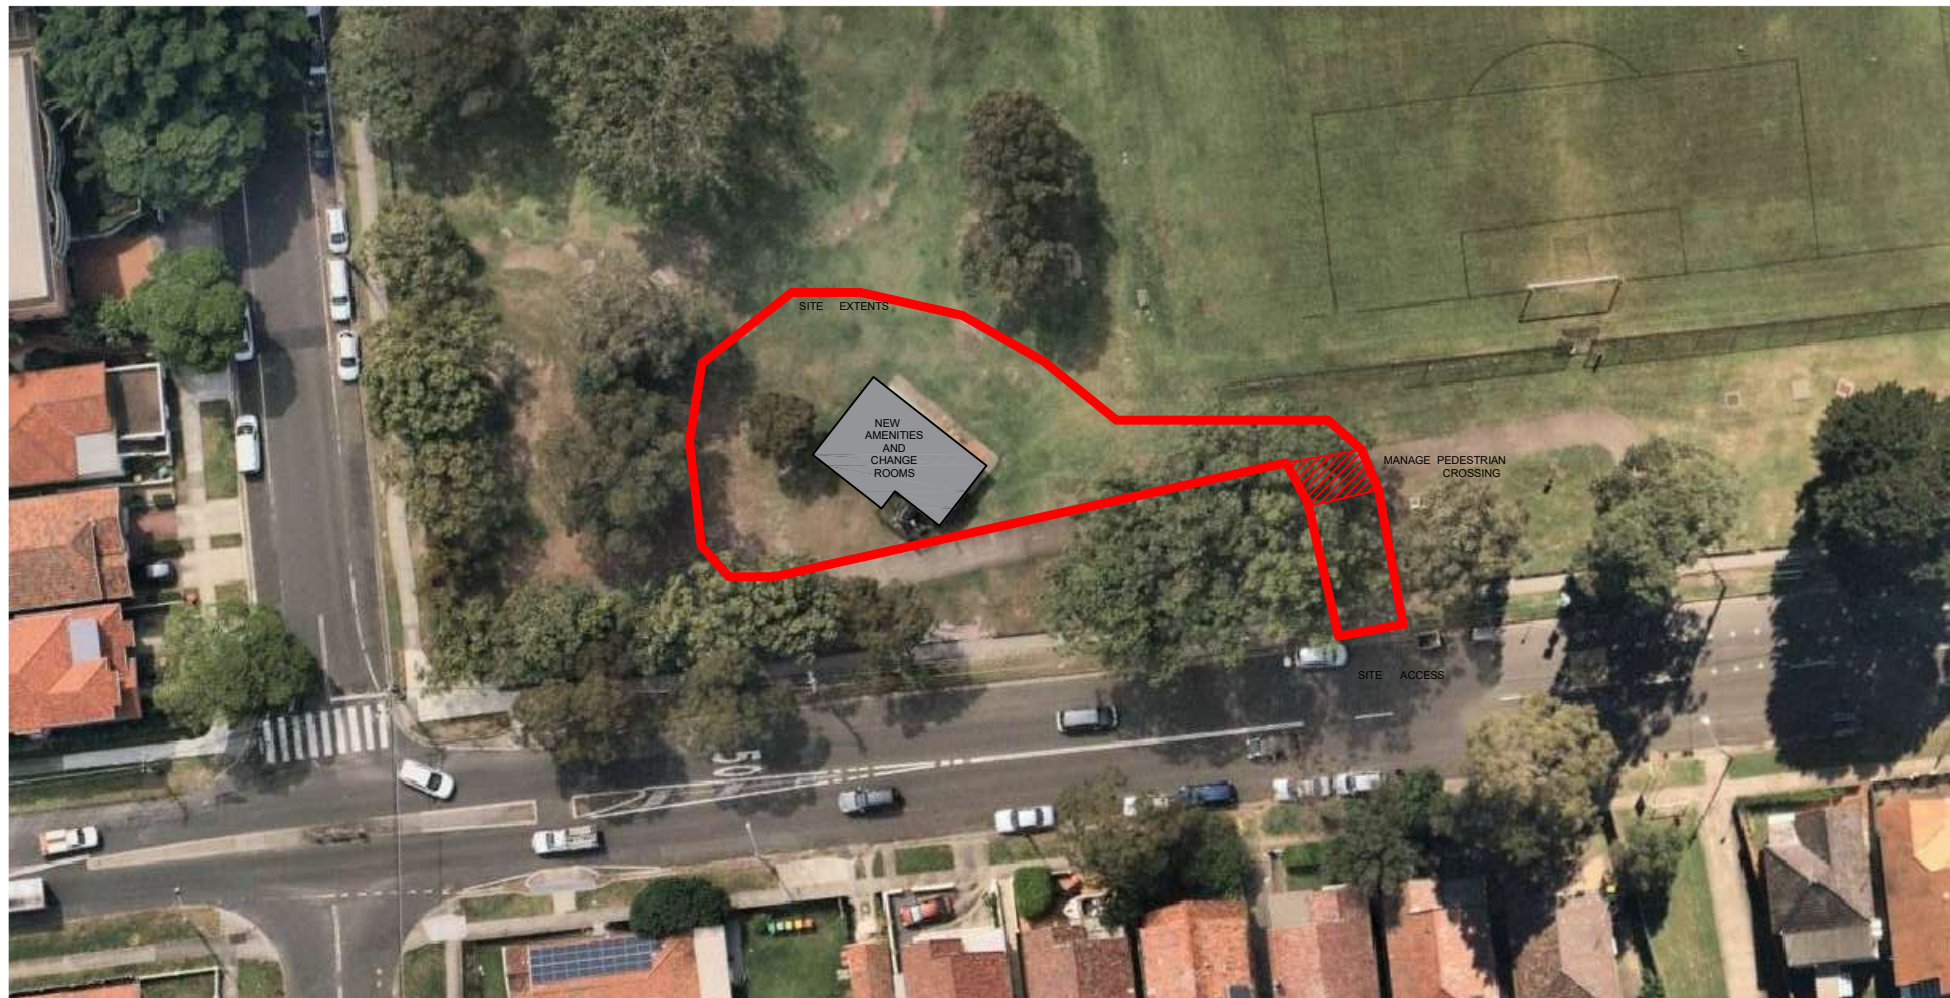


DRAWING SCHEDULE

SHEET NO.	SHEET TITLE	REVISION
001	COVER SHEET/SITE PLAN	A
002	DEMOLITION PLAN	A
003	FLOOR PLAN	A
004	ELEVATIONS	A

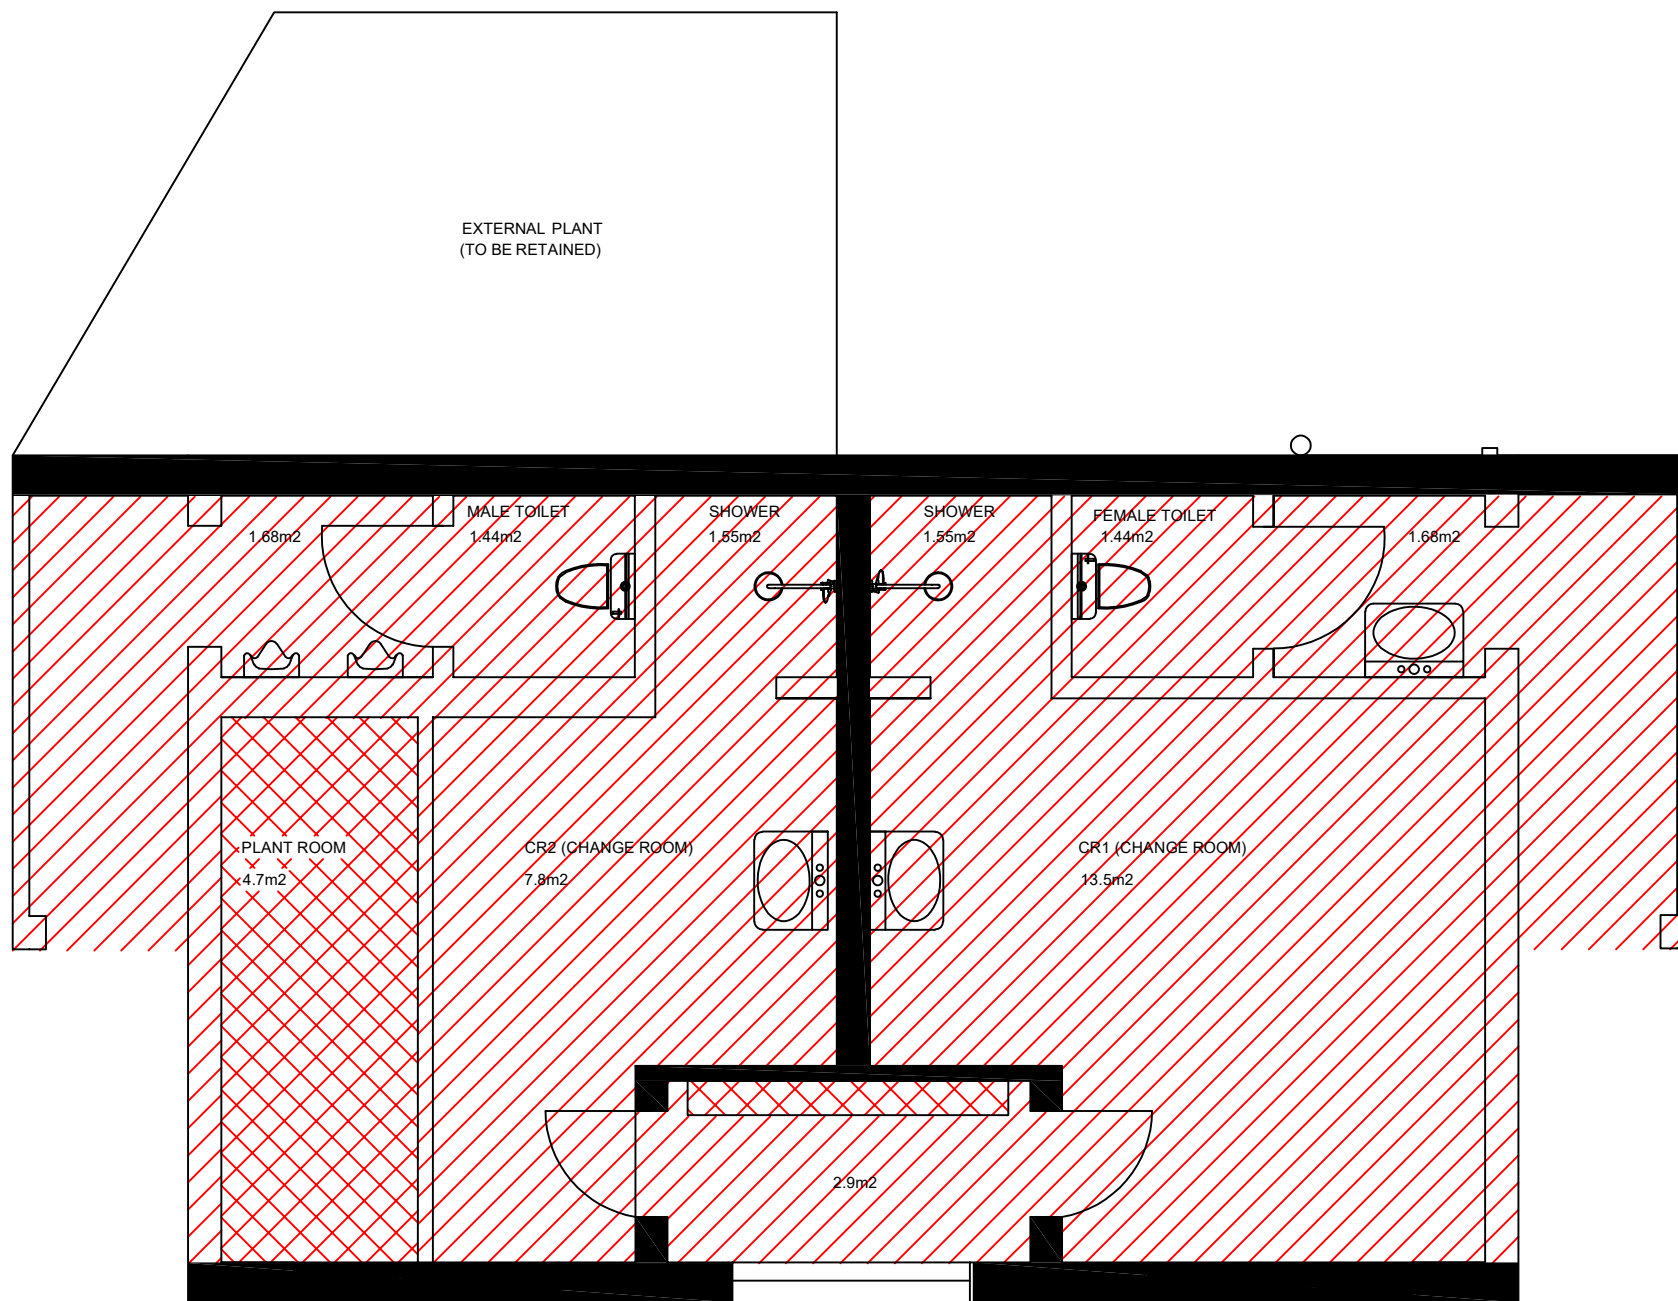PUBLIC UTILITY LEGEND					NOTE VERIFY ALL DIMENSIONS AND LEVELS ON SITE PRIOR TO THE COMMENCEMENT OF WORK. DO NOT SCALE FROM DRAWINGS. CAD FILE W:\ICSVTS\Design\Archive	PLAN - NOT TO SCALE		SECTIONS-		CITY OF RANDWICK		PLAN NUMBER		
DATE	ISSUED TO	ISSUE	APP'D	COMMENTS/AMENDMENTS		DRAWN	DATE	SURVEYED	DATUM	COVER SHEET / SITE PLAN		DRAWING No.	No. OF DRAWINGS	ISSUE
						SH	SEP-21	NA	NA	PAINE RESERVE AMENITIES BLOCK		1	4	A
						DESIGNED	SEP-21	PROJECTS - INFRASTRUCTURE SERVICES		RANDWICK CITY COUNCIL				
						CHECKED	SEP-21							




LEGEND


-  DEMOLISH WALLS, CEILING, INTERNAL FIXTURES AND FITTINGS
-  WALLS TO BE RETAINED
-  REMOVE PLANT AND EQUIPMENT FOR RELOCATION

01
001 Demolition Plan
1:50


				PUBLIC UTILITY LEGEND		NOTE VERIFY ALL DIMENSIONS AND LEVELS ON SITE PRIOR TO THE COMMENCEMENT OF WORK. DO NOT SCALE FROM DRAWINGS.	PLAN - NOT TO SCALE		SECTIONS- HORZ : NA VERT : NA		CITY OF RANDWICK DEMOLITION PLAN PAINE RESERVE AMENITIES BLOCK RANDWICK CITY COUNCIL			PLAN NUMBER		
				GAS MAIN	G		DRAWN	DATE	SURVEYED	DATUM				DRAWING No.	No. OF DRAWINGS	ISSUE
				SEWER MAIN	S	SH	SEP-21	NA	NA	2	4	A				
				TELECOM CABLE	T	DESIGNED	DATE	PROJECTS - INFRASTRUCTURE SERVICES								
				WATER MAIN	W	SH	SEP-21	DATE.....								
				ELECTRICITY CABLE	E	CHECKED	DATE									
DATE	ISSUED TO	ISSUE	APP'D	TELECOM PIT	SEWER MANHOLE	CAD FILE										
				HYDRANT	STOP VALVE	W:\CS\TS\Design\Archive										

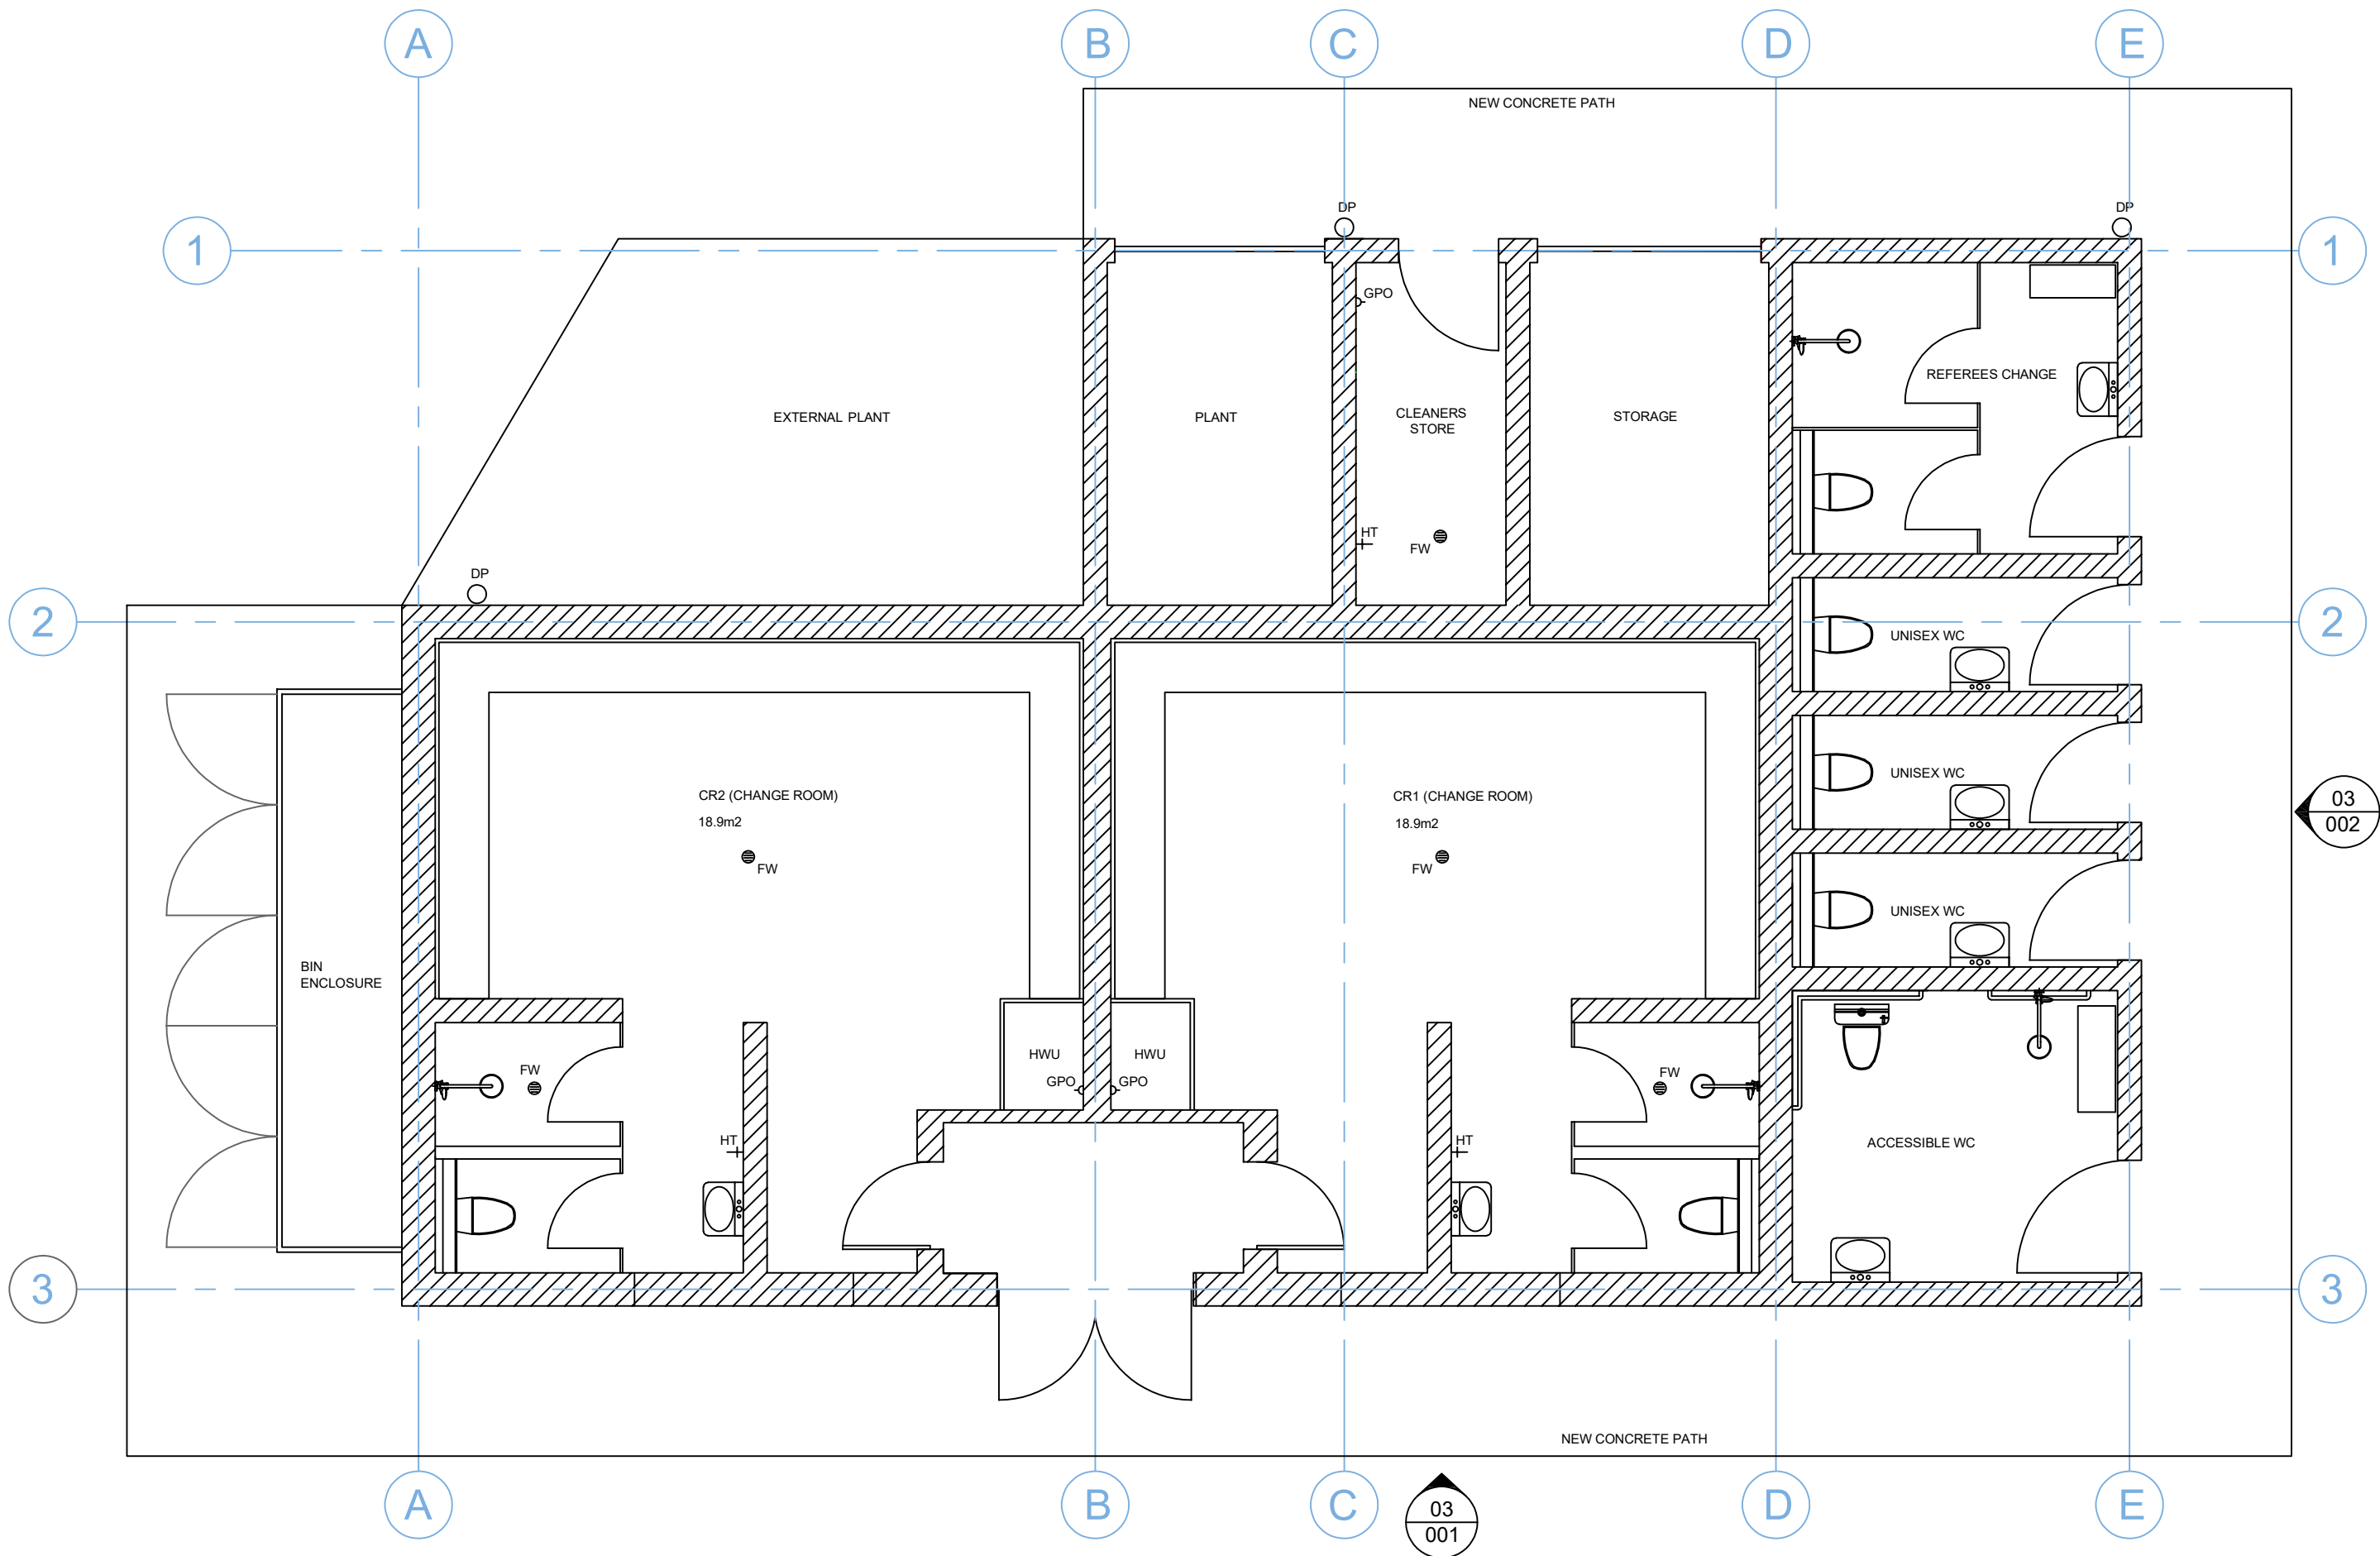

				PUBLIC UTILITY LEGEND GAS MAIN — G — SEWER MAIN — S — TELECOM CABLE — T — WATER MAIN — W — ELECTRICITY CABLE — E — TELECOM PIT — [Symbol] — HYDRANT — [Symbol] —		NOTE VERIFY ALL DIMENSIONS AND LEVELS ON SITE PRIOR TO THE COMMENCEMENT OF WORK. DO NOT SCALE FROM DRAWINGS. CAD FILE W:\CS\ITS\Design\Archive		PLAN - NOT TO SCALE DRAWN SH DESIGNED SH CHECKED		SECTIONS- DATE SEP-21 DATE SEP-21 DATE SEP-21		HORZ : NA VERT : NA DATUM NA PROJECTS - INFRASTRUCTURE SERVICES		CITY OF RANDWICK FLOOR PLANS Paine Reserve Amenities Block RANDWICK CITY COUNCIL			PLAN NUMBER DRAWING No. 3 No. OF DRAWINGS 4 ISSUE A		
--	--	--	--	--	--	---	--	---	--	--	--	--	--	---	--	--	--	--	--

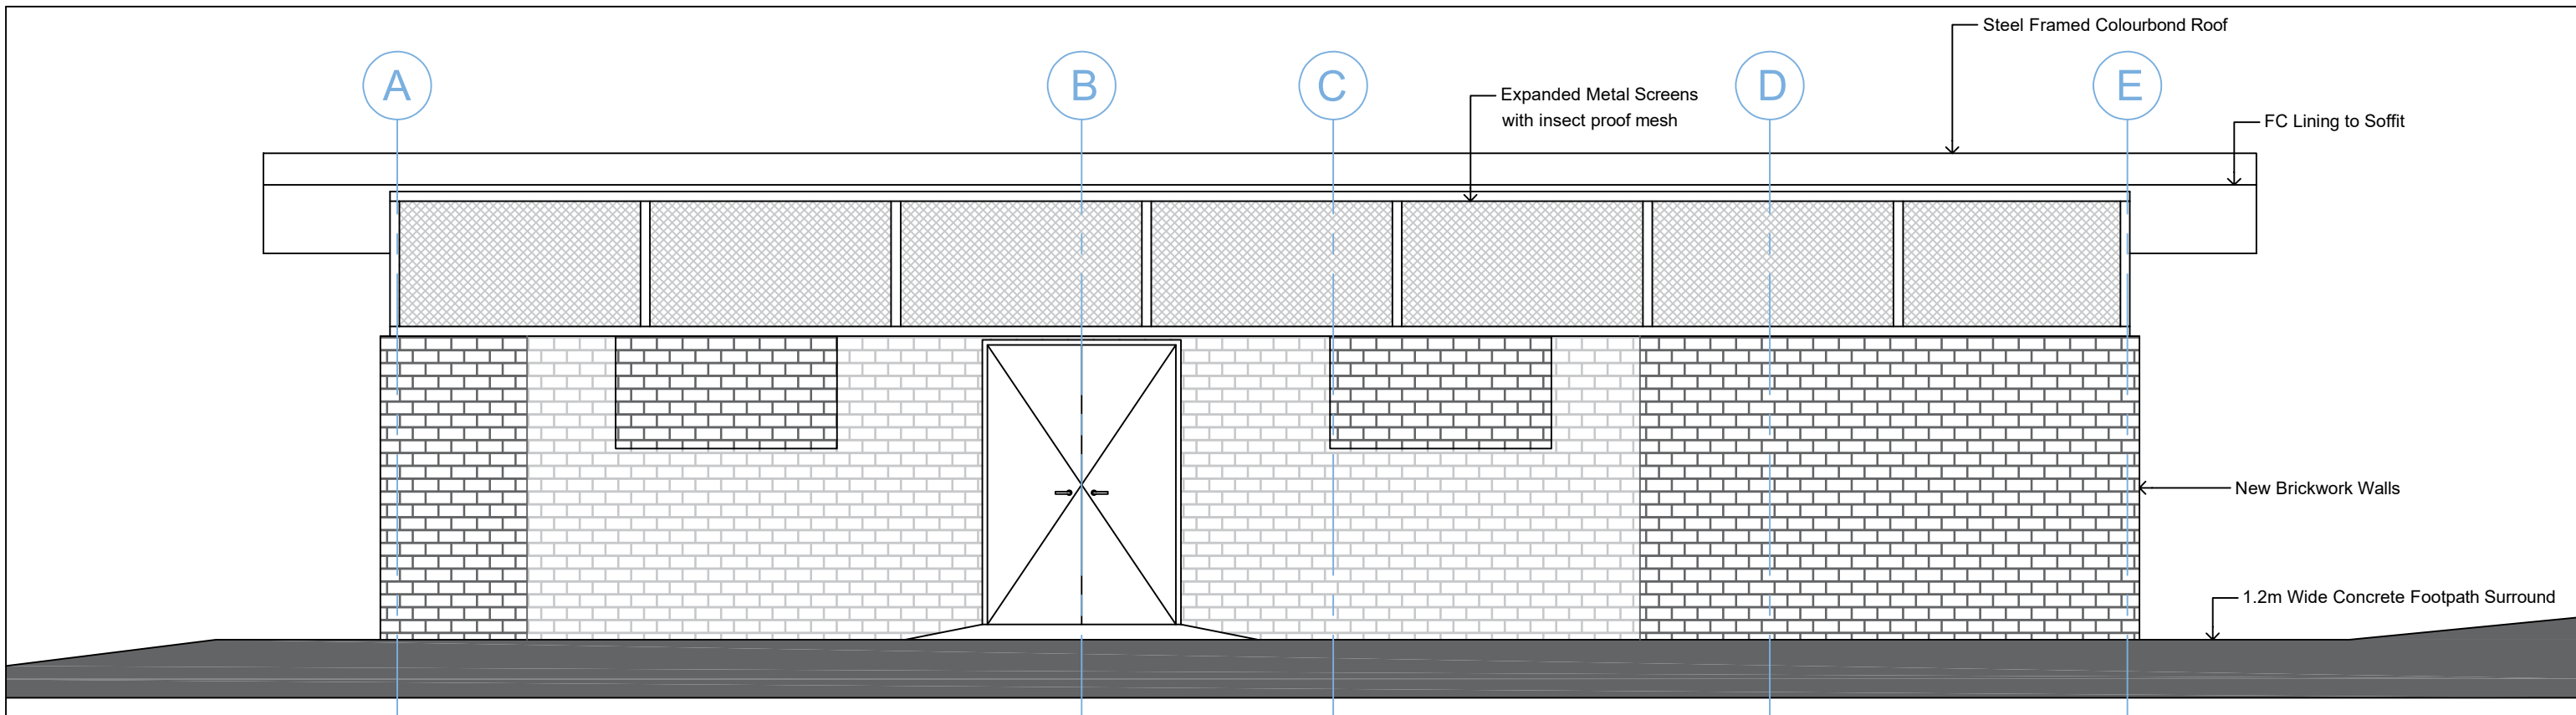

03
001 East Elevation
1:50

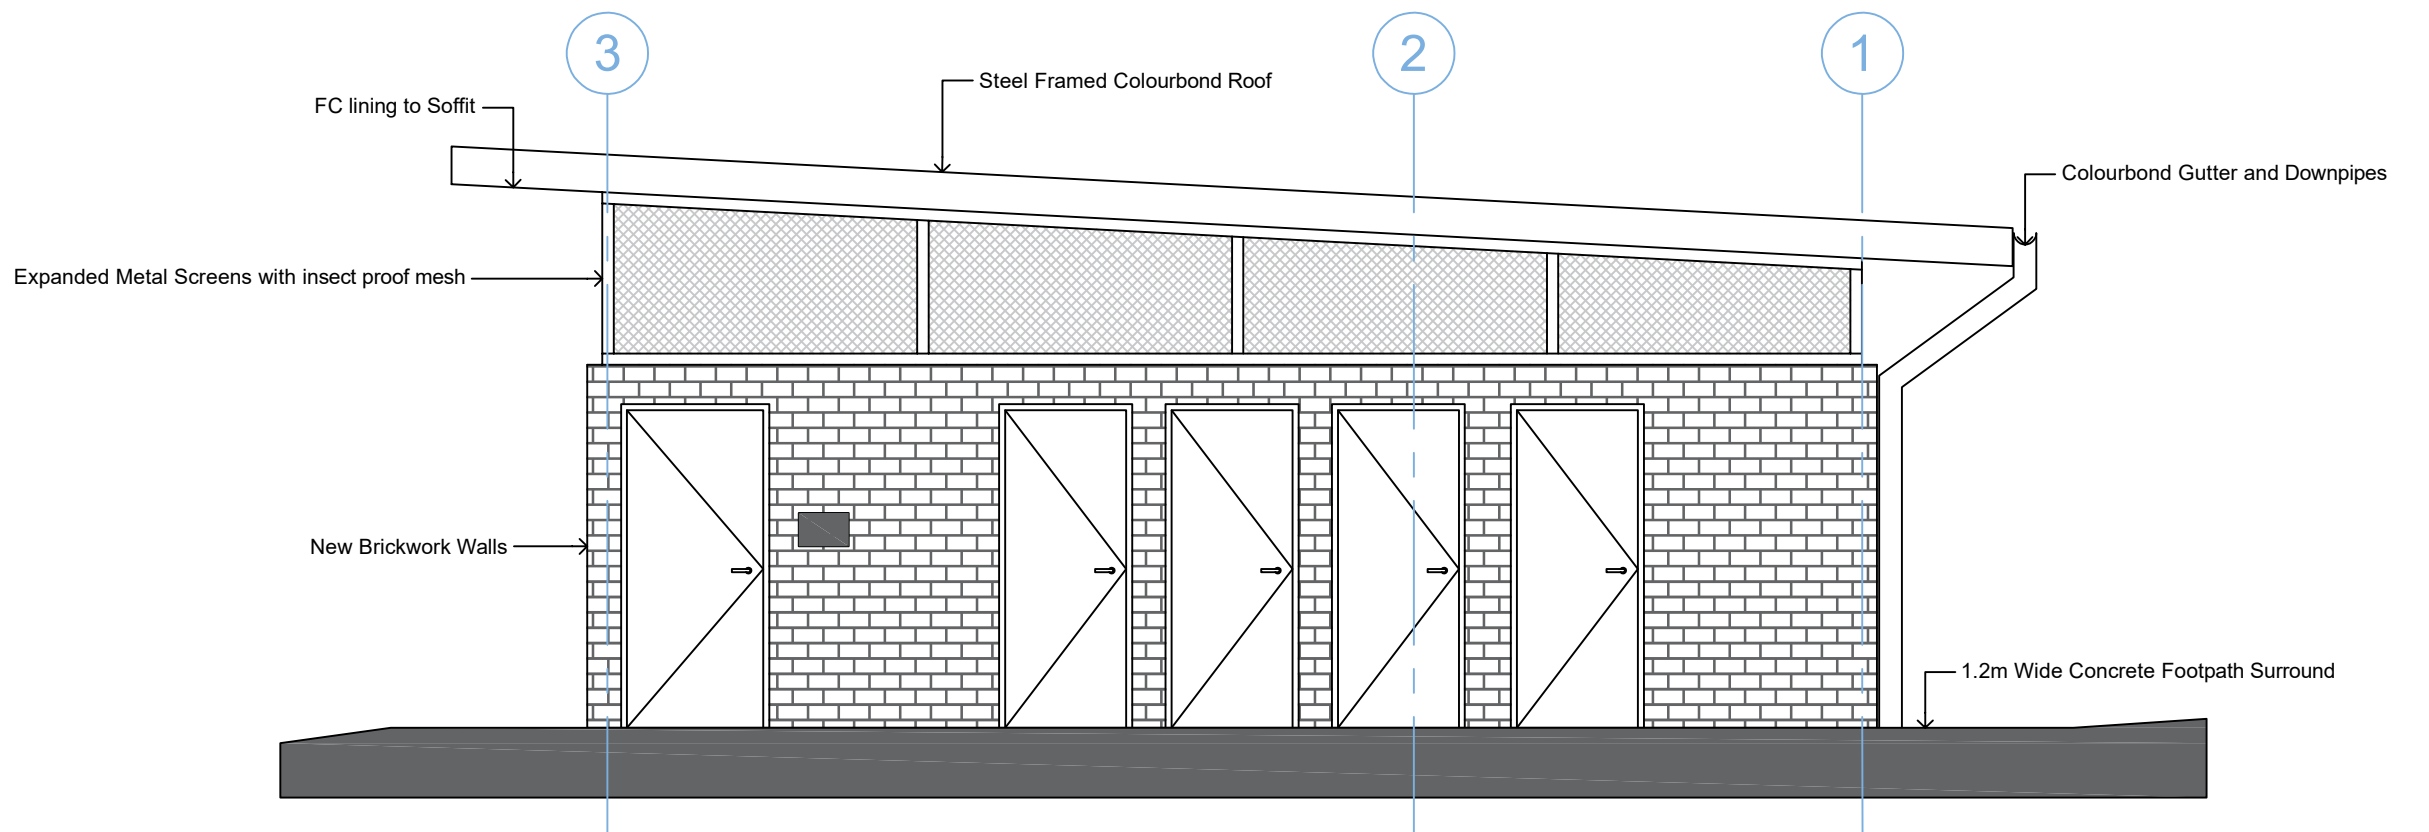

03
002 North Elevation
1:50

					PUBLIC UTILITY LEGEND		NOTE		PLAN - NOT TO SCALE		SECTIONS-		HORZ : NA VERT : NA		CITY OF RANDWICK ELEVATIONS			PLAN NUMBER		
					GAS MAIN	G	VERIFY ALL DIMENSIONS AND LEVELS ON SITE PRIOR TO THE COMMENCEMENT OF WORK. DO NOT SCALE FROM DRAWINGS.		DRAWN	DATE	SURVEYED	DATUM	PROJECTS - INFRASTRUCTURE SERVICES							
					SEWER MAIN	S	CAD FILE		SH	SEP-21	NA	NA				RANDWICK CITY COUNCIL			4	4
					TELECOM CABLE	T	W:\CS\T\Design\Archive		DESIGNED	DATE	DATE	DATE								
					WATER MAIN	W			SH	SEP-21	DATE	DATE								
					ELECTRICITY CABLE	E			CHECKED	SEP-21	DATE	DATE								
DATE	ISSUED TO	ISSUE	APP'D	COMMENTS/AMENDMENTS	TELECOM PIT	SEWER MANHOLE														
					HYDRANT	STOP VALVE														